


1.4. Water facilities
are functional and
well-distributed in
all buildings.

LEGEND:



WATER SYSTEM

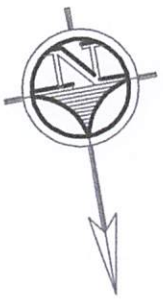

TO SURIGAO NORTE HIGH SCHOOL

TO PROVINCIAL GRANDSTAND

SURIGAO CITY PILOT SCHOOL

MAGALLANES EXTENSION

TO PILOT SCHOOL

TO MC DONALD




GROUND FLOOR PLAN

SCALE 1:500 M.

LOGO:	BY DIRECT SUPERVISION:	PROJECT TITLE:	RECOMMENDING APPROVAL :	APPROVED:	SHEET CONTENTS:	SHEET NO.:
	 AR. MARLON C. SOLOSO	WATER SYSTEM LAYOUT	 ROWENA A. PANDO, Ph.D.	 GREGORIO Z. GAMBOA, JR., Ed.D.		
SSCT	HEAD BUILDINGS & ESTATES	LOCATION: SSCT-MAIN CAMPUS, NARCISO ST., SURIGAO CITY	VICE-PRESIDENT for ADMINISTRATION	COLLEGE PRESIDENT		

SURIGAO STATE COLLEGE OF TECHNOLOGY
MAIN CAMPUS, SURIGAO CITY

LEGEND:

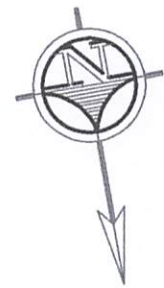

TO SURIGAO NORTE HIGH SCHOOL



TO PROVINCIAL GRANDSTAND



TO PILOT SCHOOL N A R C I S O S T R E E T TO MC DONALD

SECOND FLOOR PLAN


SCALE 1:500 M.

LOGO:	BY DIRECT SUPERVISION:	PROJECT TITLE:	RECOMMENDING APPROVAL :	APPROVED:	SHEET CONTENTS:	SHEET NO.:
	 AR. MARLON C. SOLLOSO HEAD BUILDINGS & ESTATES	WATER SYSTEM LAYOUT	 ROWENA A. PANDO, Ph.D. VICE-PRESIDENT for ADMINISTRATION	 GREGORIO Z. GAMBOA, JR., Ed.D. COLLEGE PRESIDENT		
SSCT		LOCATION: SSCT-MAIN CAMPUS, NARCISO ST., SURIGAO CITY				

LEGEND:

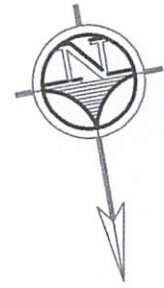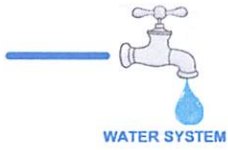

TO SURIGAO NORTE HIGH SCHOOL

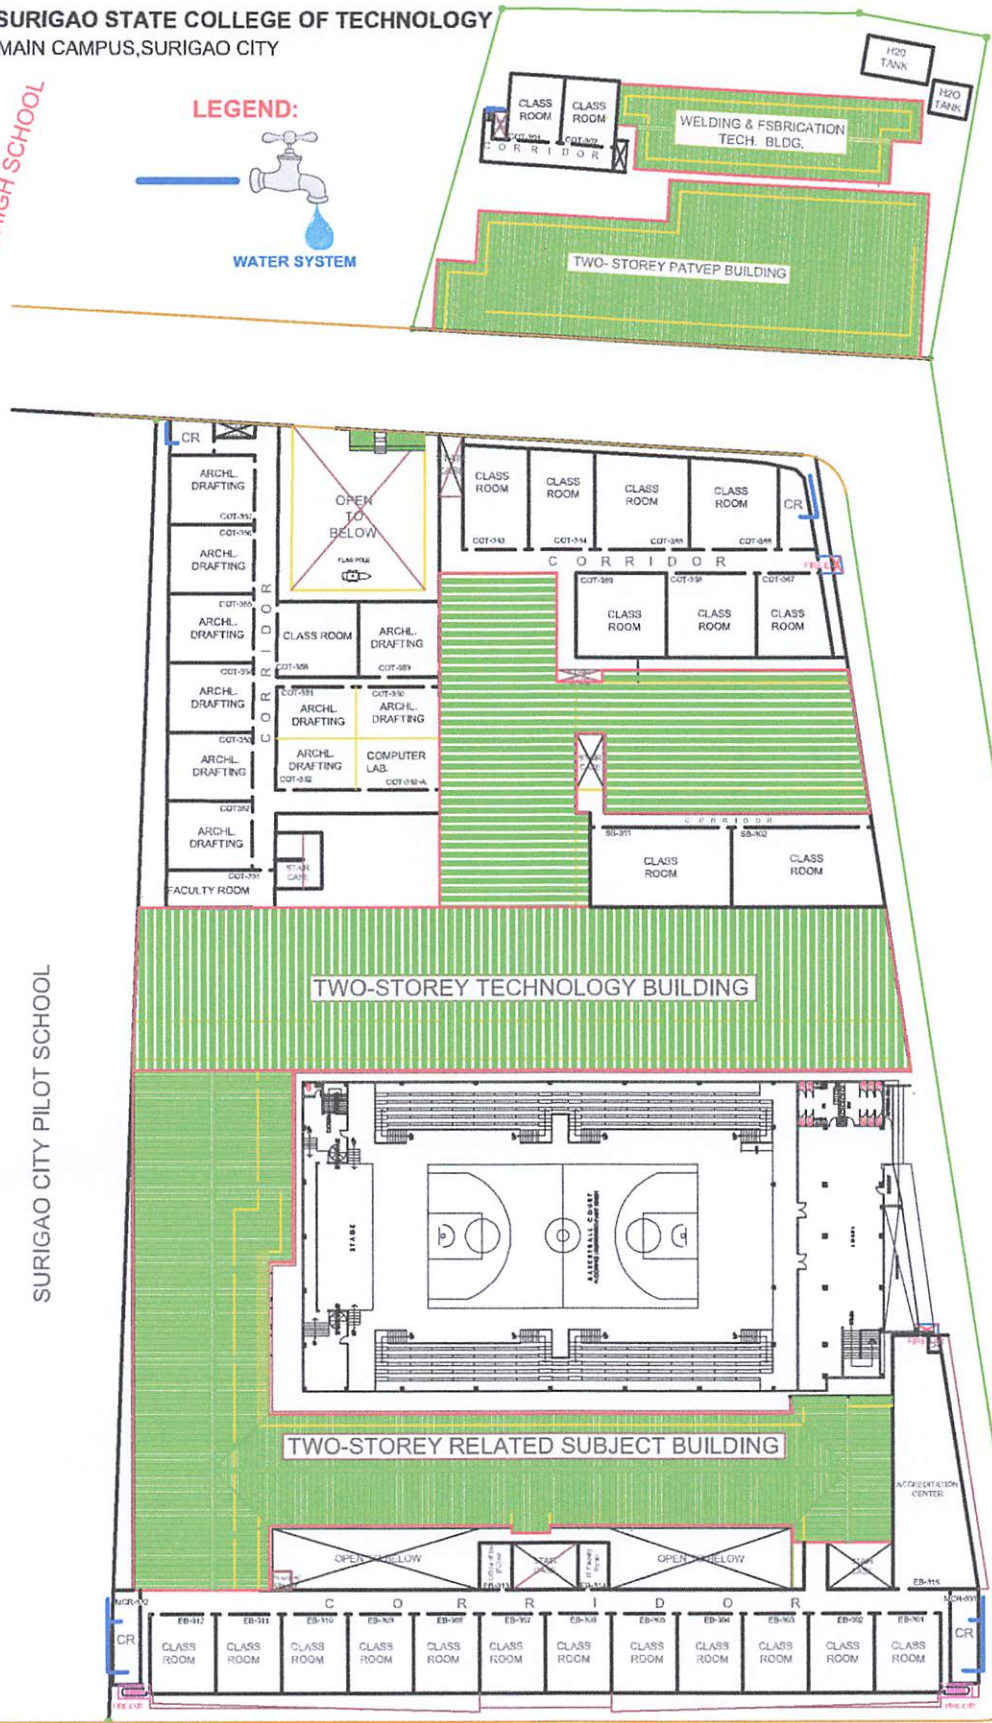

TO PROVINCIAL GRANDSTAND



N A R C I S O S T R E E T TO PILOT SCHOOL TO MC DONALD

THIRD FLOOR PLAN

SCALE 1:500 M.

LOGO:	BY DIRECT SUPERVISION:	PROJECT TITLE:	RECOMMENDING APPROVAL :	APPROVED:	SHEET CONTENTS:	SHEET NO.:
	 AR. MARLON C. SOLLOSO	WATER SYSTEM LAYOUT	 ROWENA A. PANDO, Ph.D.	 GREGORIO Z. GAMBOA, JR., Ed.D.		
SSCT	HEAD BUILDINGS & ESTATES	LOCATION: SSCT-MAIN CAMPUS, NARCISO ST., SURIGAO CITY	VICE-PRESIDENT for ADMINISTRATION	COLLEGE PRESIDENT		

LEGEND:



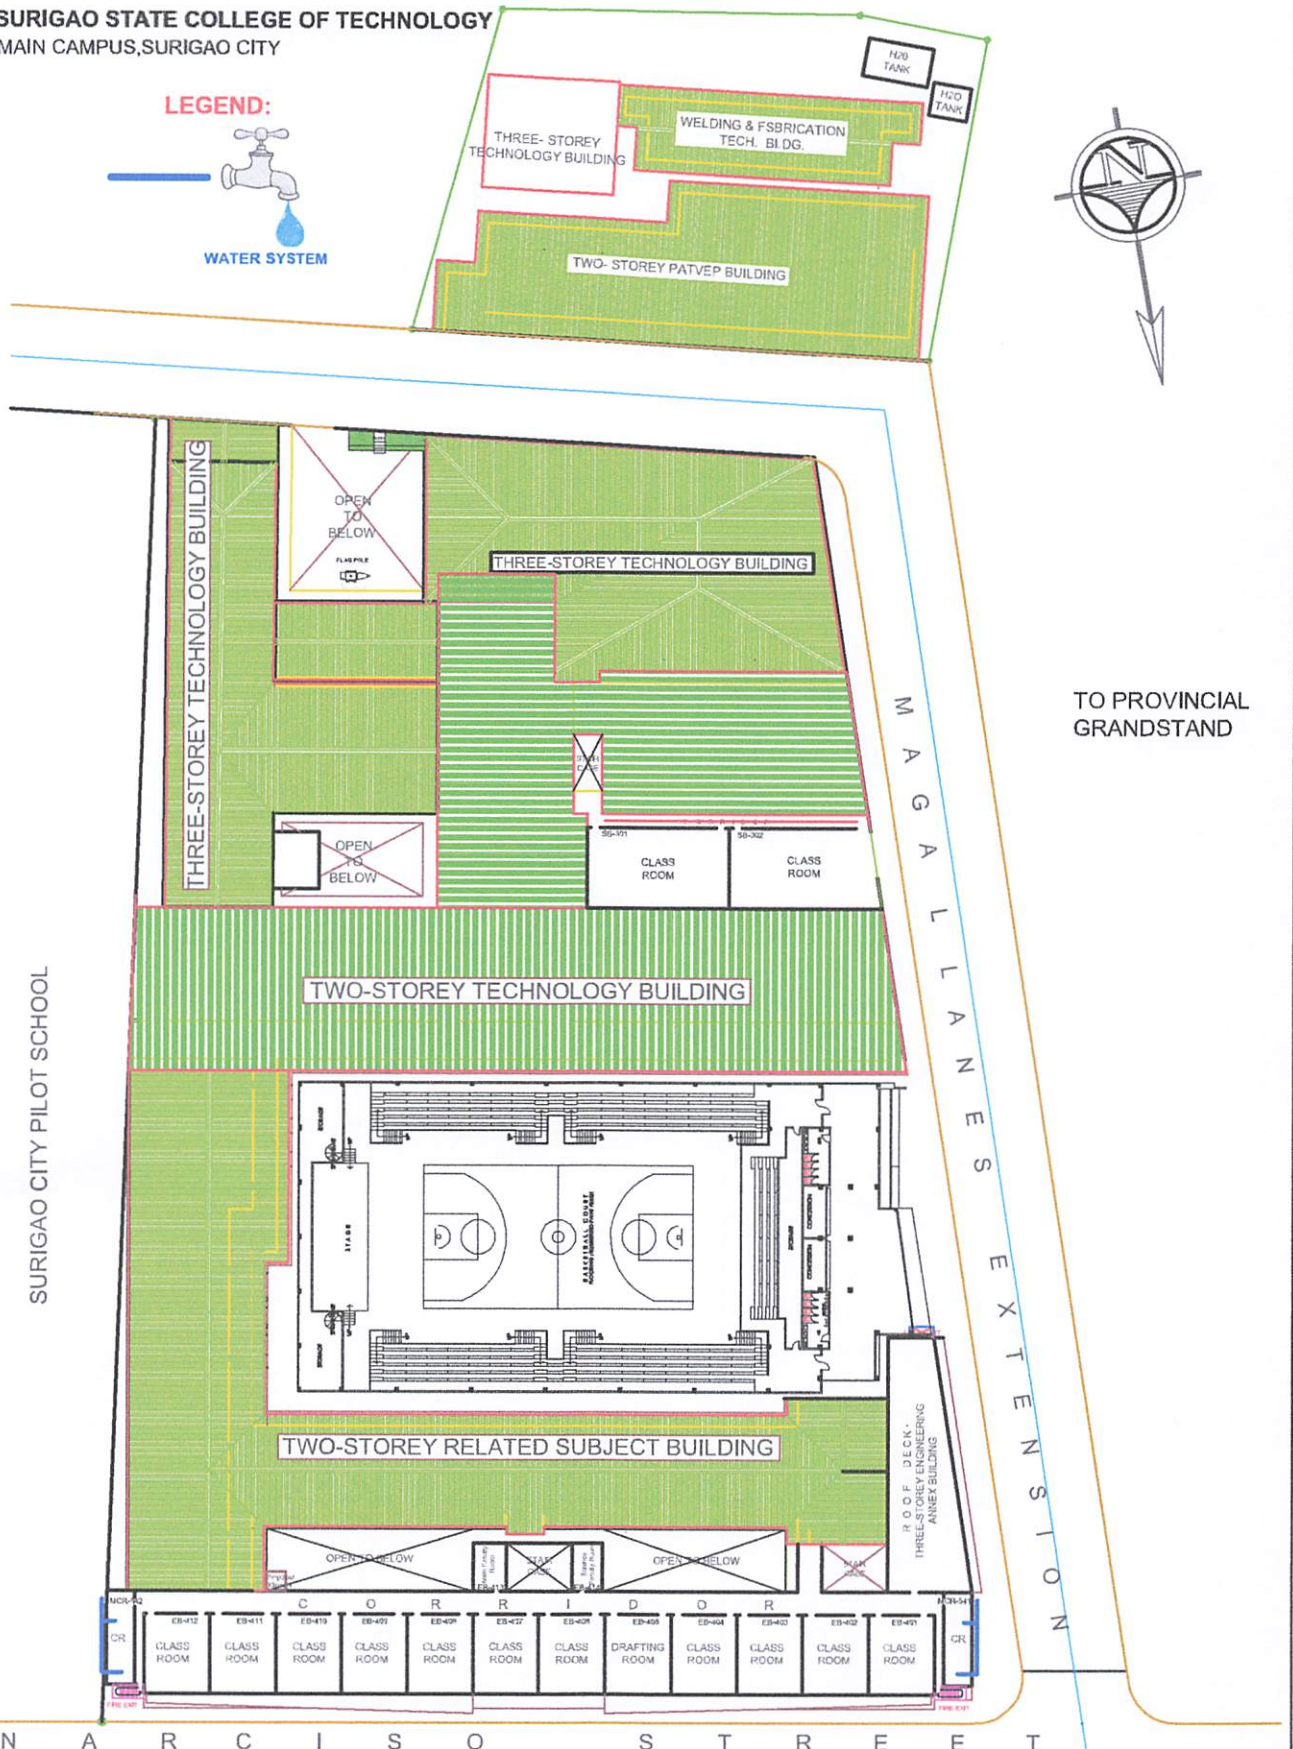
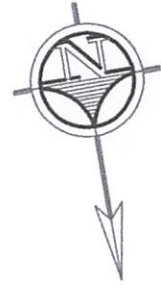


FOURTH FLOOR PLAN

SCALE 1:500 M.

LOGO:	BY DIRECT SUPERVISION:	PROJECT TITLE:	RECOMMENDING APPROVAL :	APPROVED:	SHEET CONTENTS:	SHEET NO.:
	 AR. MARLON C. SOLLOSO	WATER SYSTEM LAYOUT	 ROWENA A. PANDO, Ph.D.	 GREGORIO Z. GAMBOA, JR., Ed.D.		
SSCT	HEAD BUILDINGS & ESTATES	LOCATION: SSCT-MAIN CAMPUS, NARCISO ST., SURIGAO CITY	VICE-PRESIDENT FOR ADMINISTRATION	COLLEGE PRESIDENT		

LEGEND:

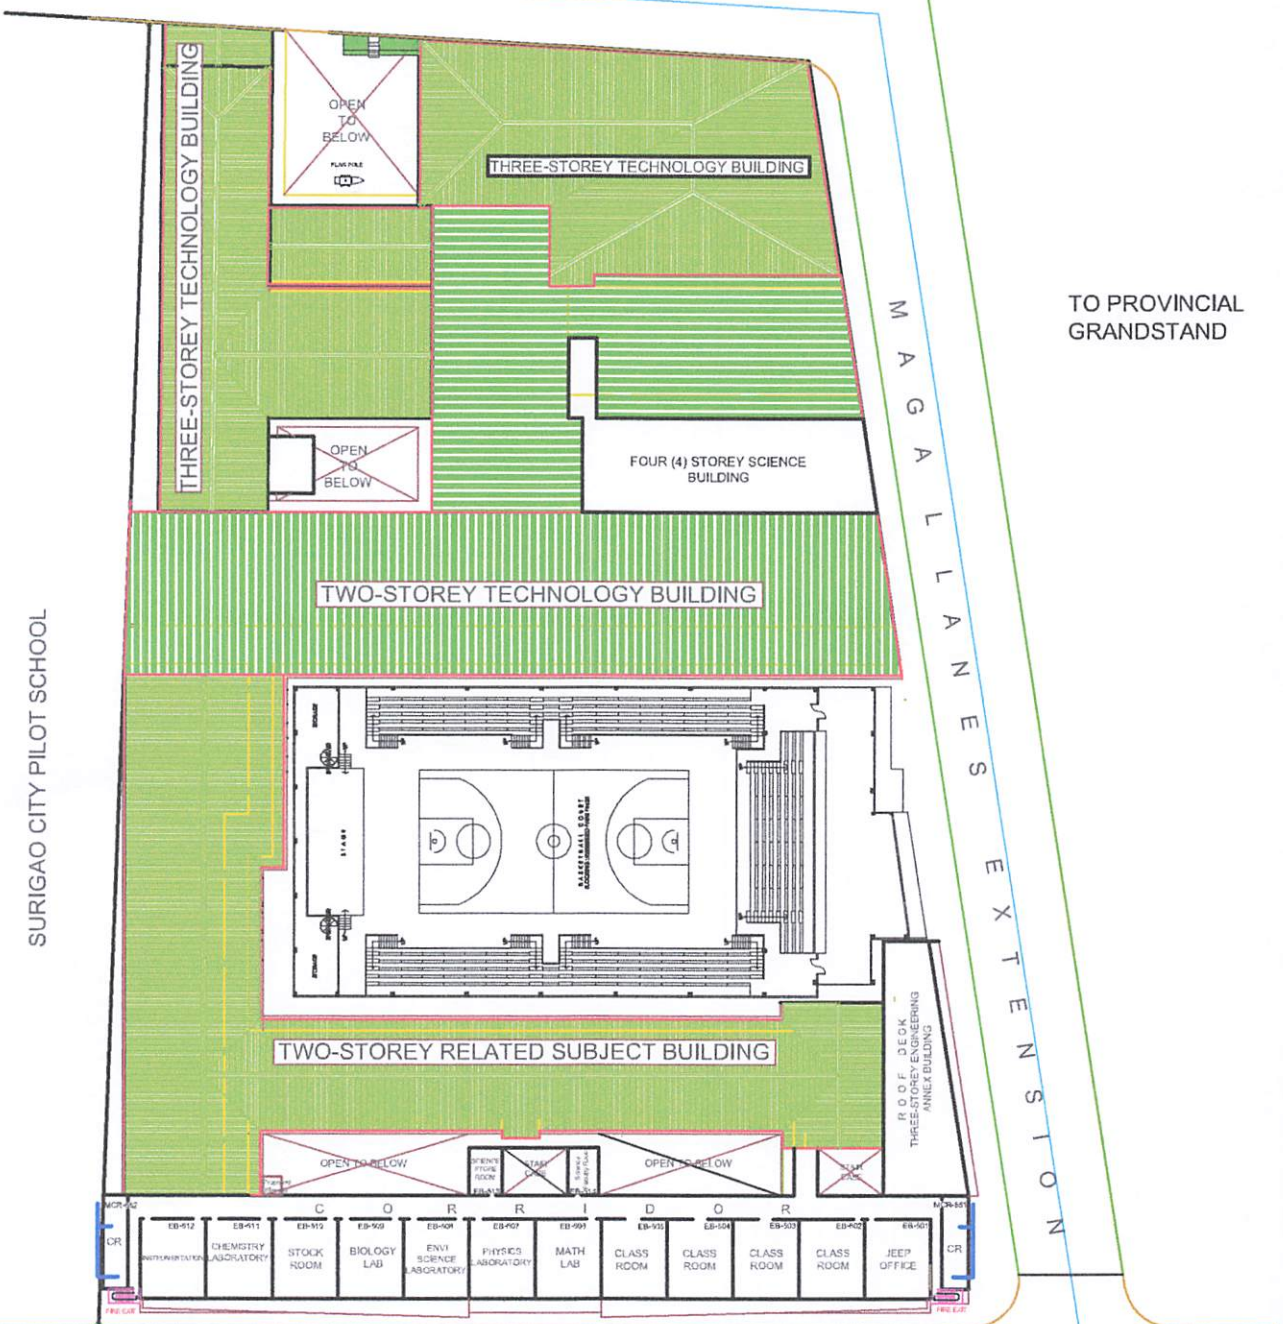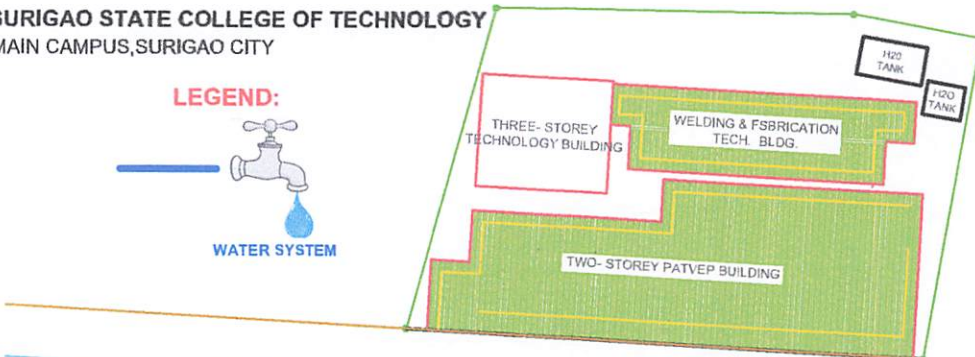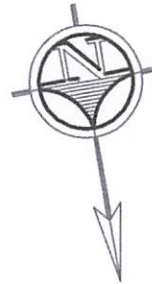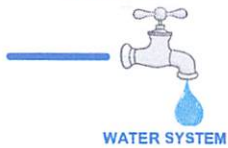

SURIGAO CITY PILOT SCHOOL

MAGALLANES EXTENSION

TO PROVINCIAL GRANDSTAND

TO PILOT SCHOOL

TO MC DONALD

FIFTH FLOOR PLAN





SCALE 1:500 M.

LOGO:	BY DIRECT SUPERVISION:	PROJECT TITLE:	RECOMMENDING APPROVAL :	APPROVED:	SHEET CONTENTS:	SHEET NO.:
	 AR. MARLON C. SOLLOSO	WATER SYSTEM LAYOUT	 ROWENA A. PANDO, Ph.D.	 GREGORIO Z. GAMBOA, JR., Ed.D.		
SSCT	HEAD BUILDINGS & ESTATES	LOCATION: SSCT-MAIN CAMPUS, NARCISO ST., SURIGAO CITY	VICE-PRESIDENT FOR ADMINISTRATION	COLLEGE PRESIDENT		

SURIGAO STATE COLLEGE OF TECHNOLOGY
MAIN CAMPUS, SURIGAO CITY

LEGEND:


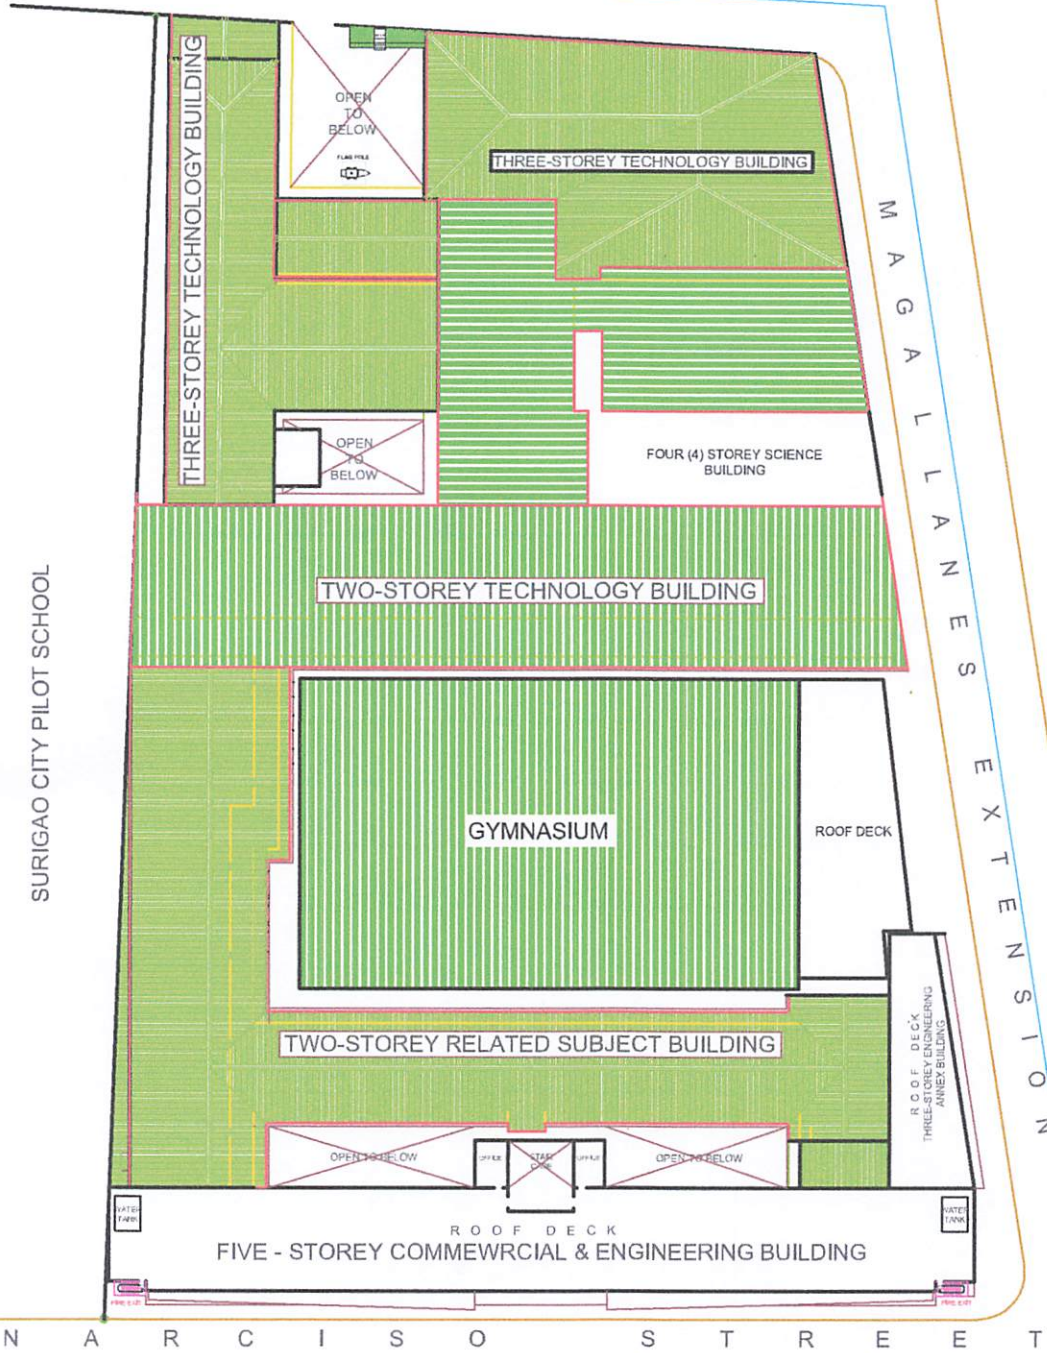
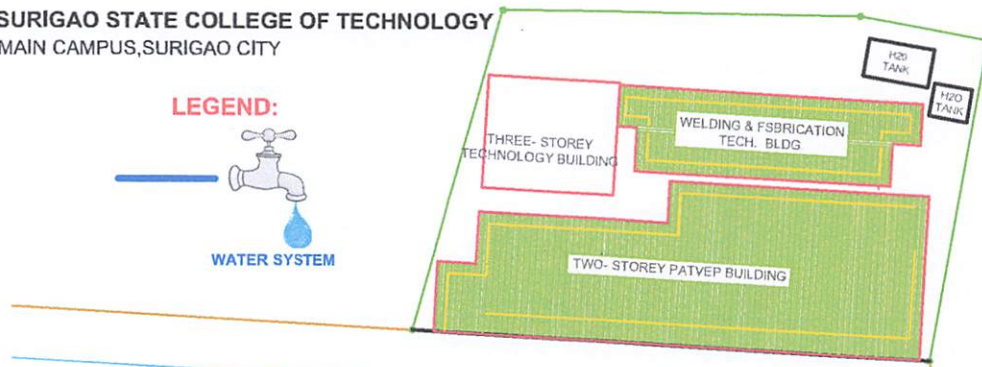


ROOF DECK PLAN

SCALE 1:550 M.

LOGO:	BY DIRECT SUPERVISION:	PROJECT TITLE:	RECOMMENDING APPROVAL :	APPROVED:	SHEET CONTENTS:	SHEET NO.:
	 AR. MARLON C. SOLLOSO	WATER SYSTEM LAYOUT	 ROWENA A. PANDO, Ph.D.	 GREGORIO Z. GAMBOA, JR., Ed.D.		
SSCT	HEAD BUILDINGS & ESTATES	LOCATION: SSCT-MAIN CAMPUS, NARCISO ST., SURIGAO CITY	VICE-PRESIDENT for ADMINISTRATION	COLLEGE PRESIDENT		



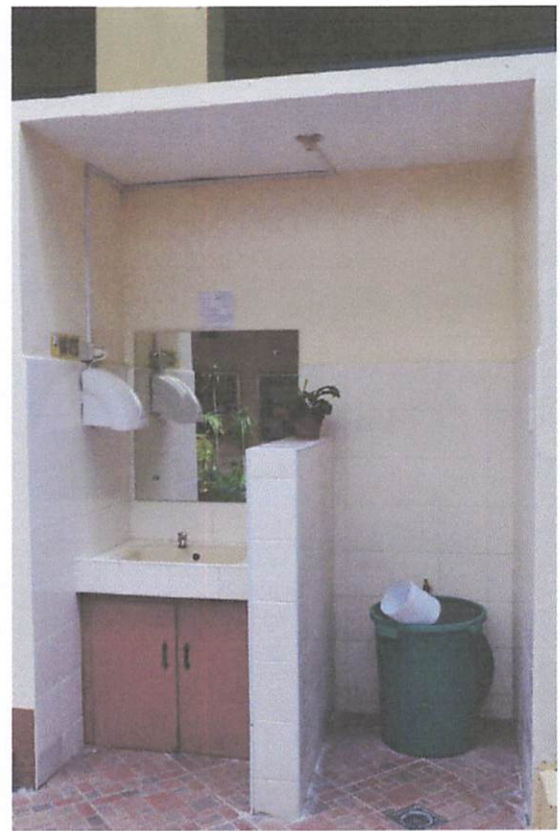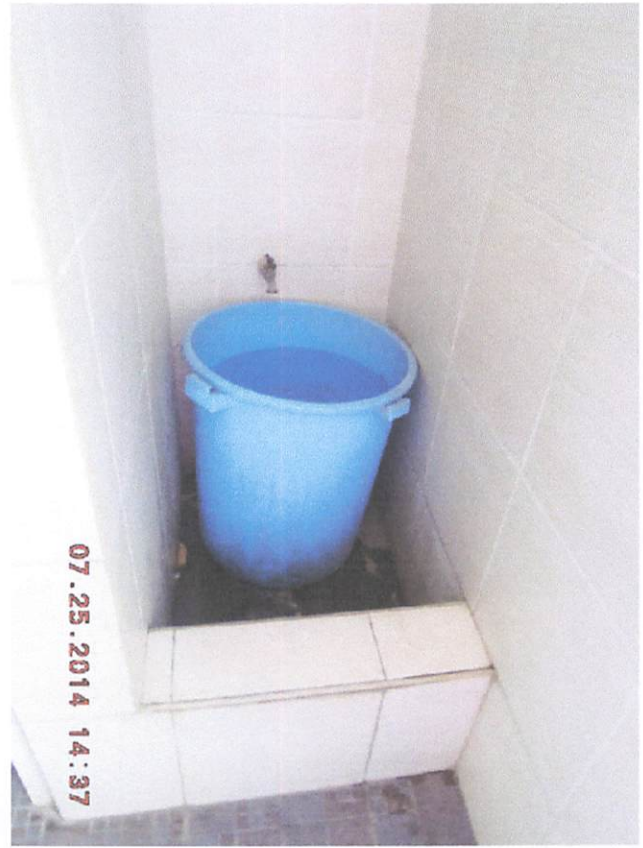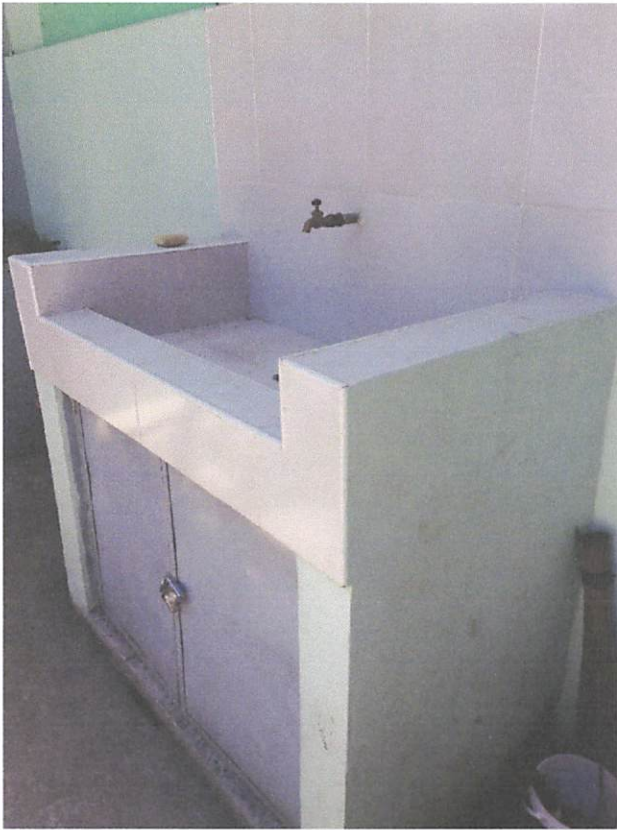

I.4 Water facilities are functional and well-distributed in all buildings